





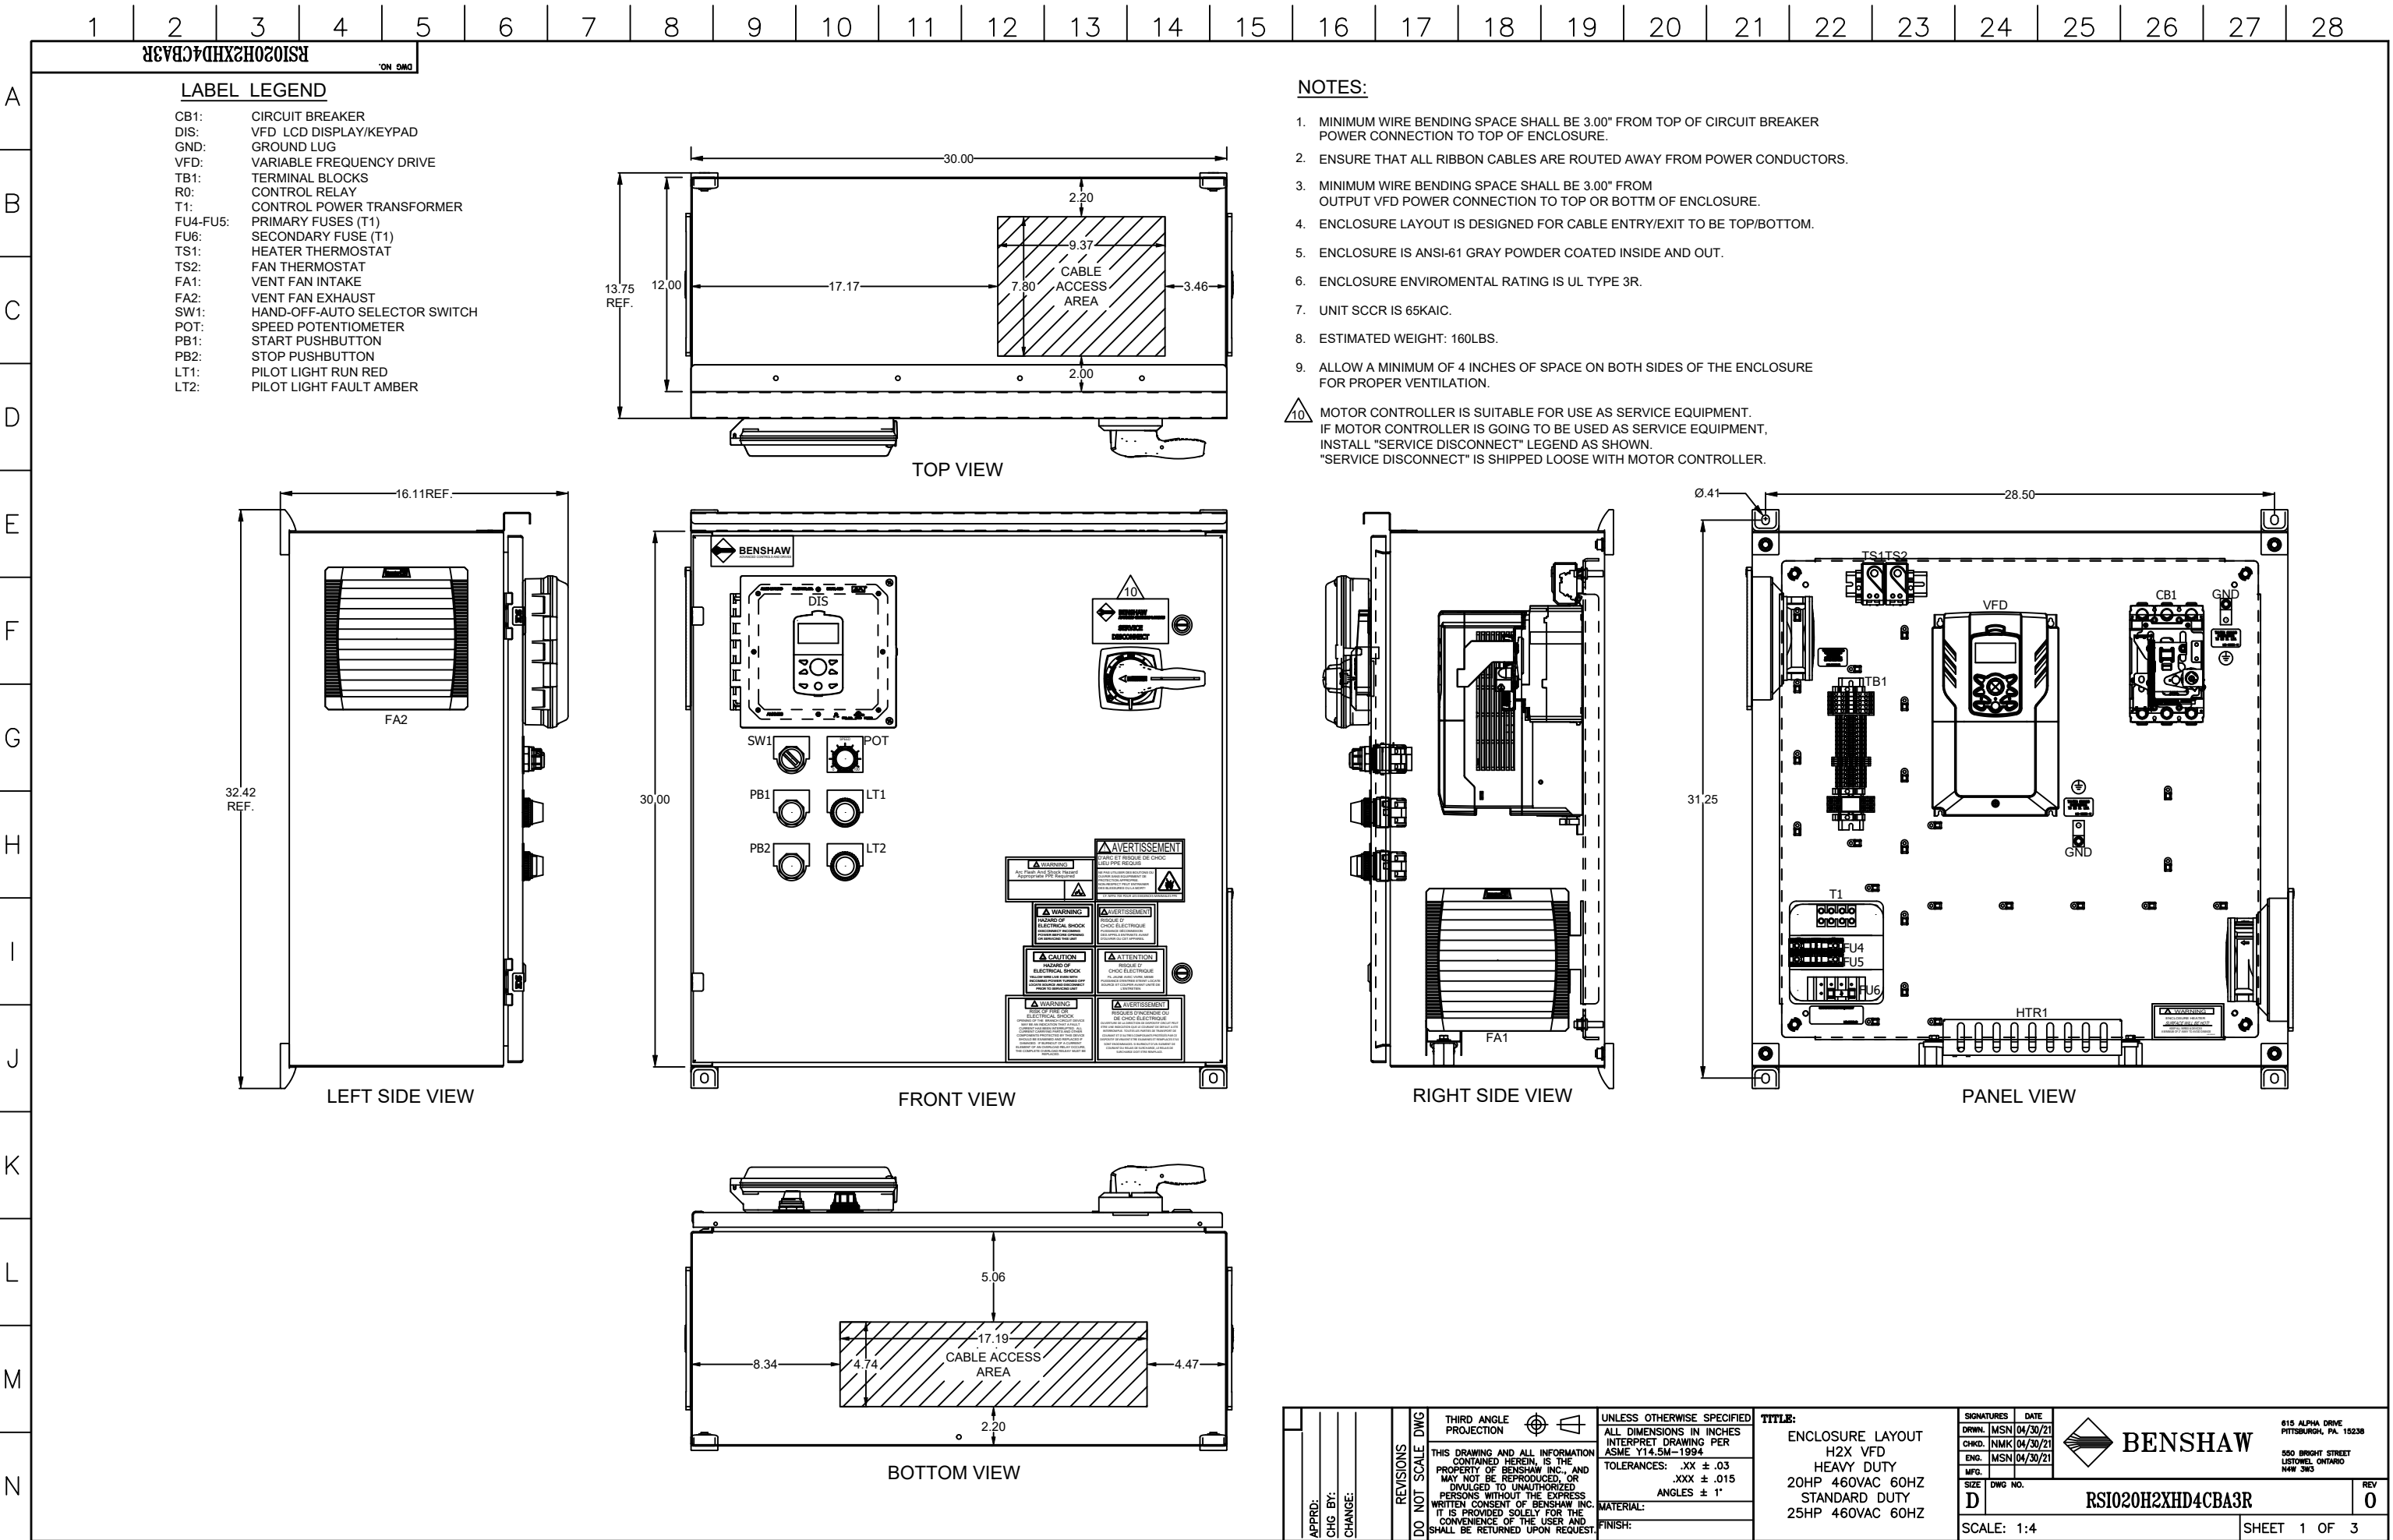

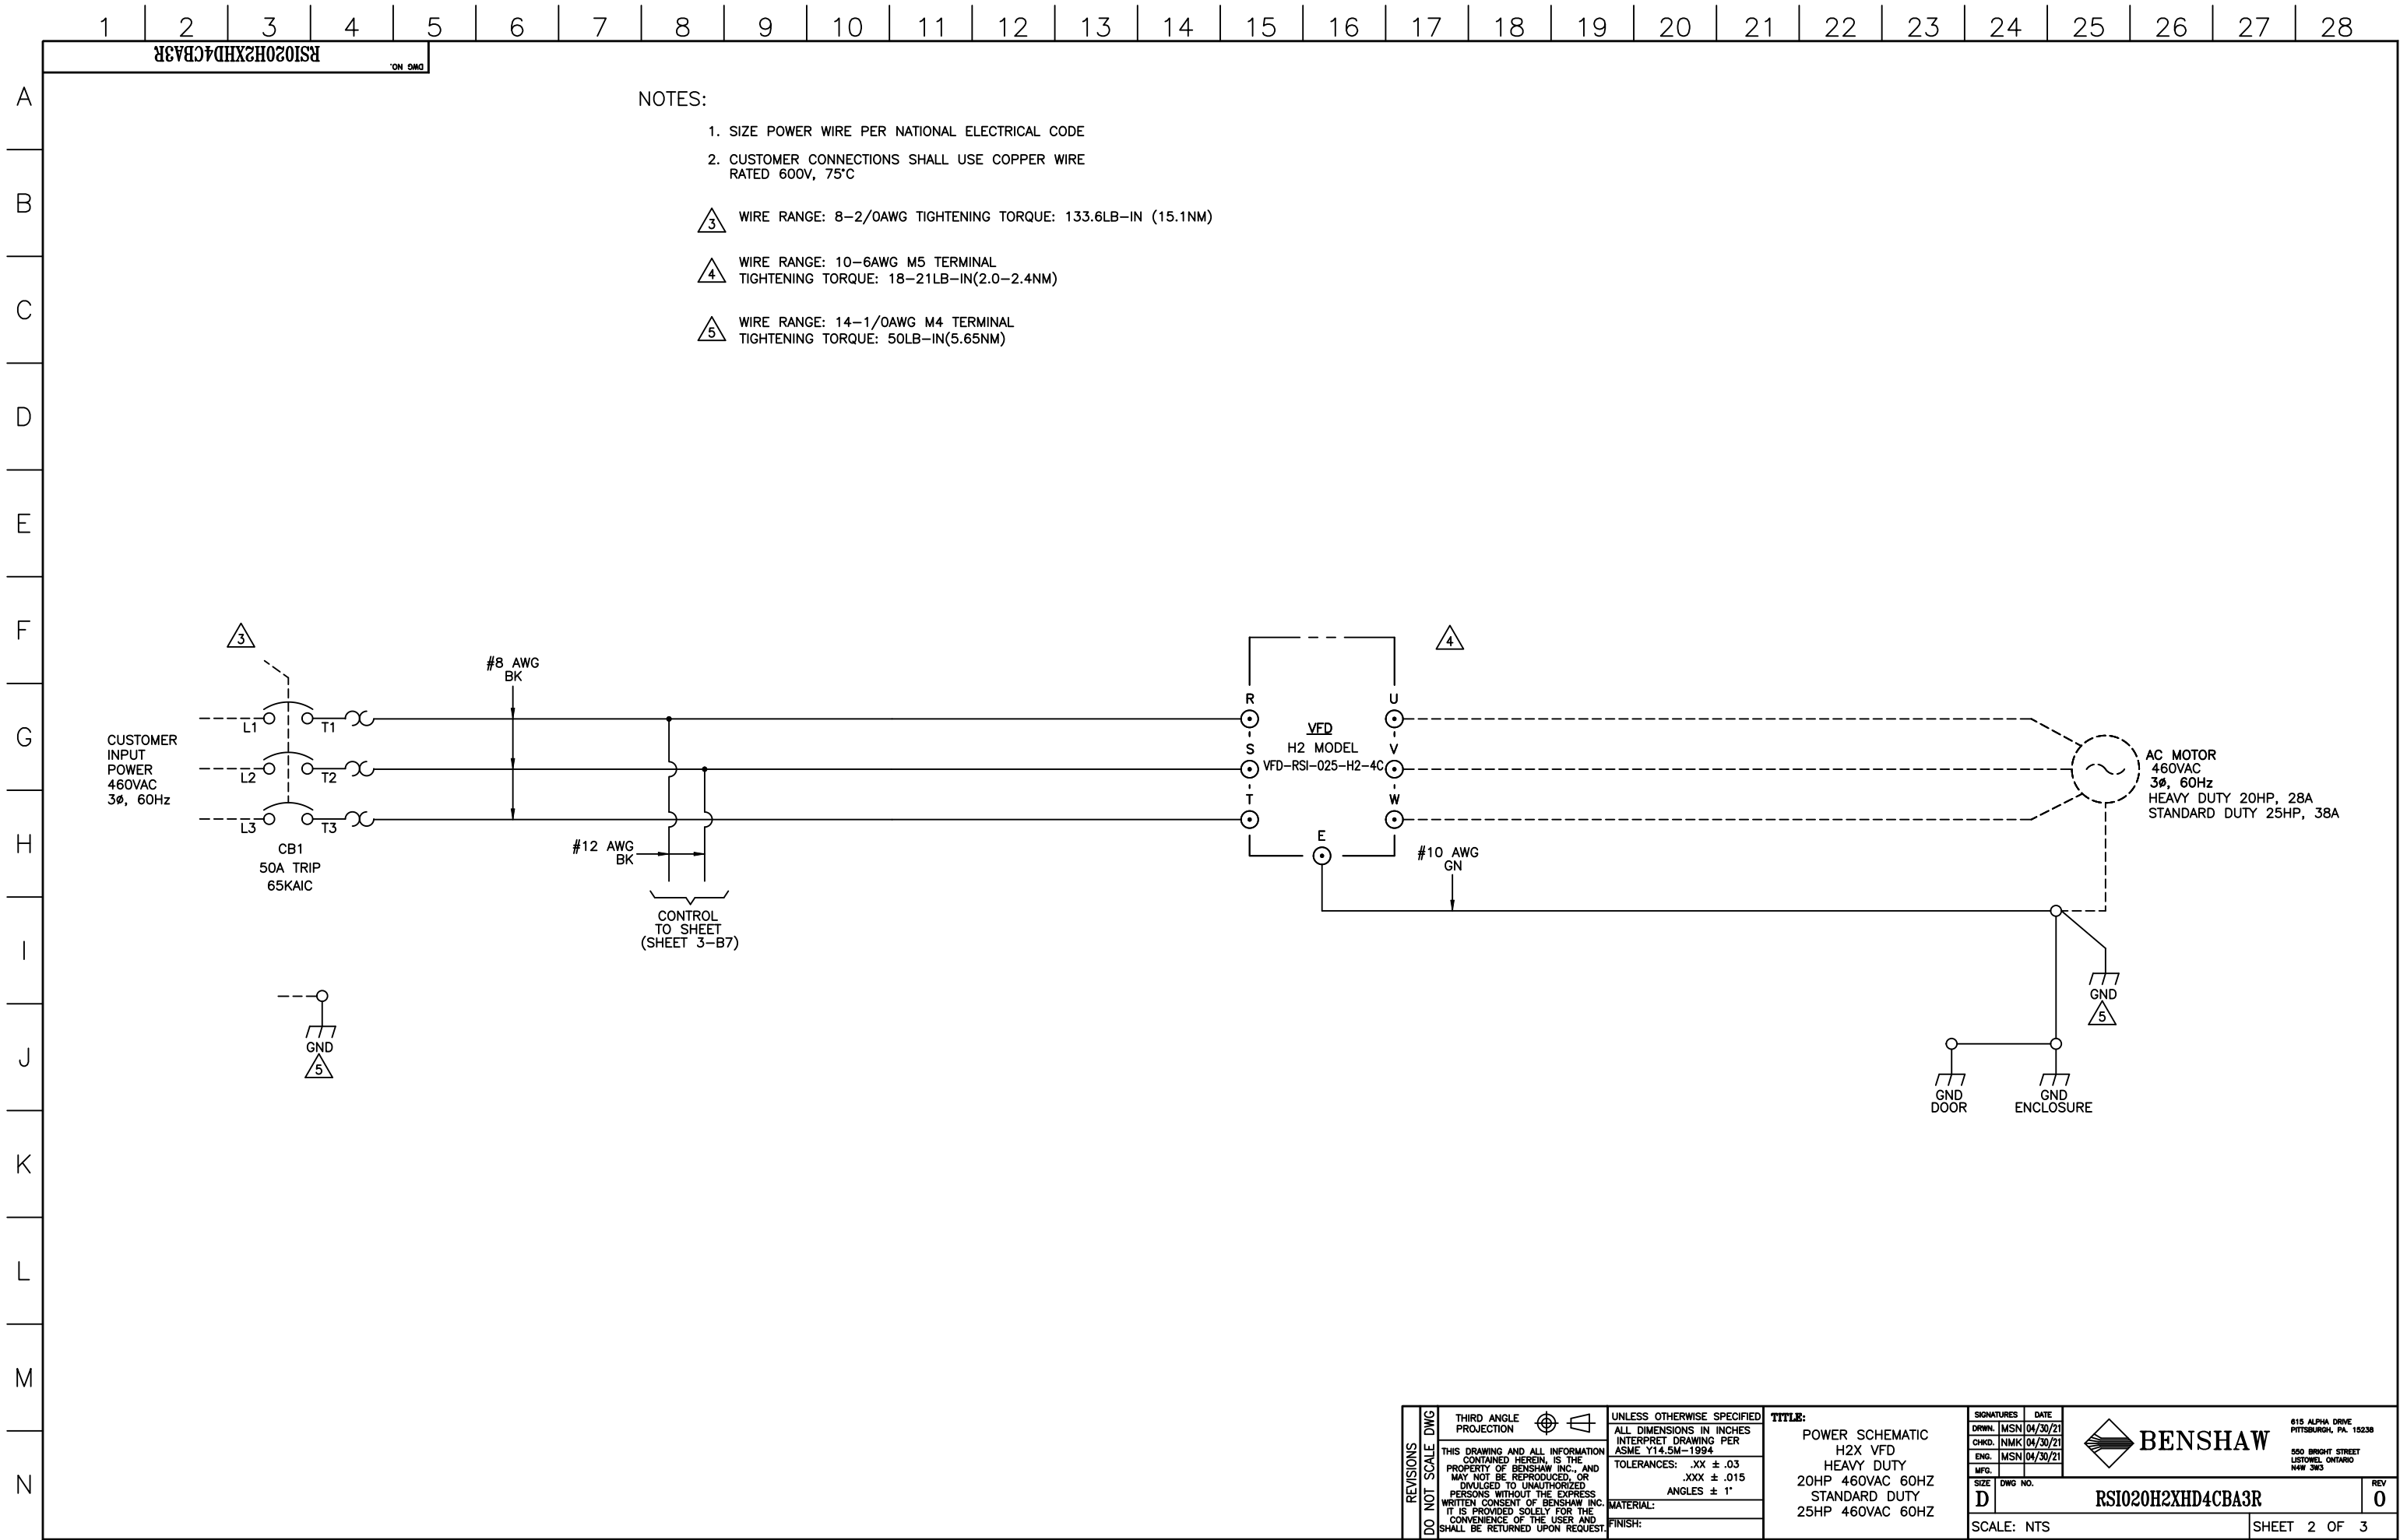

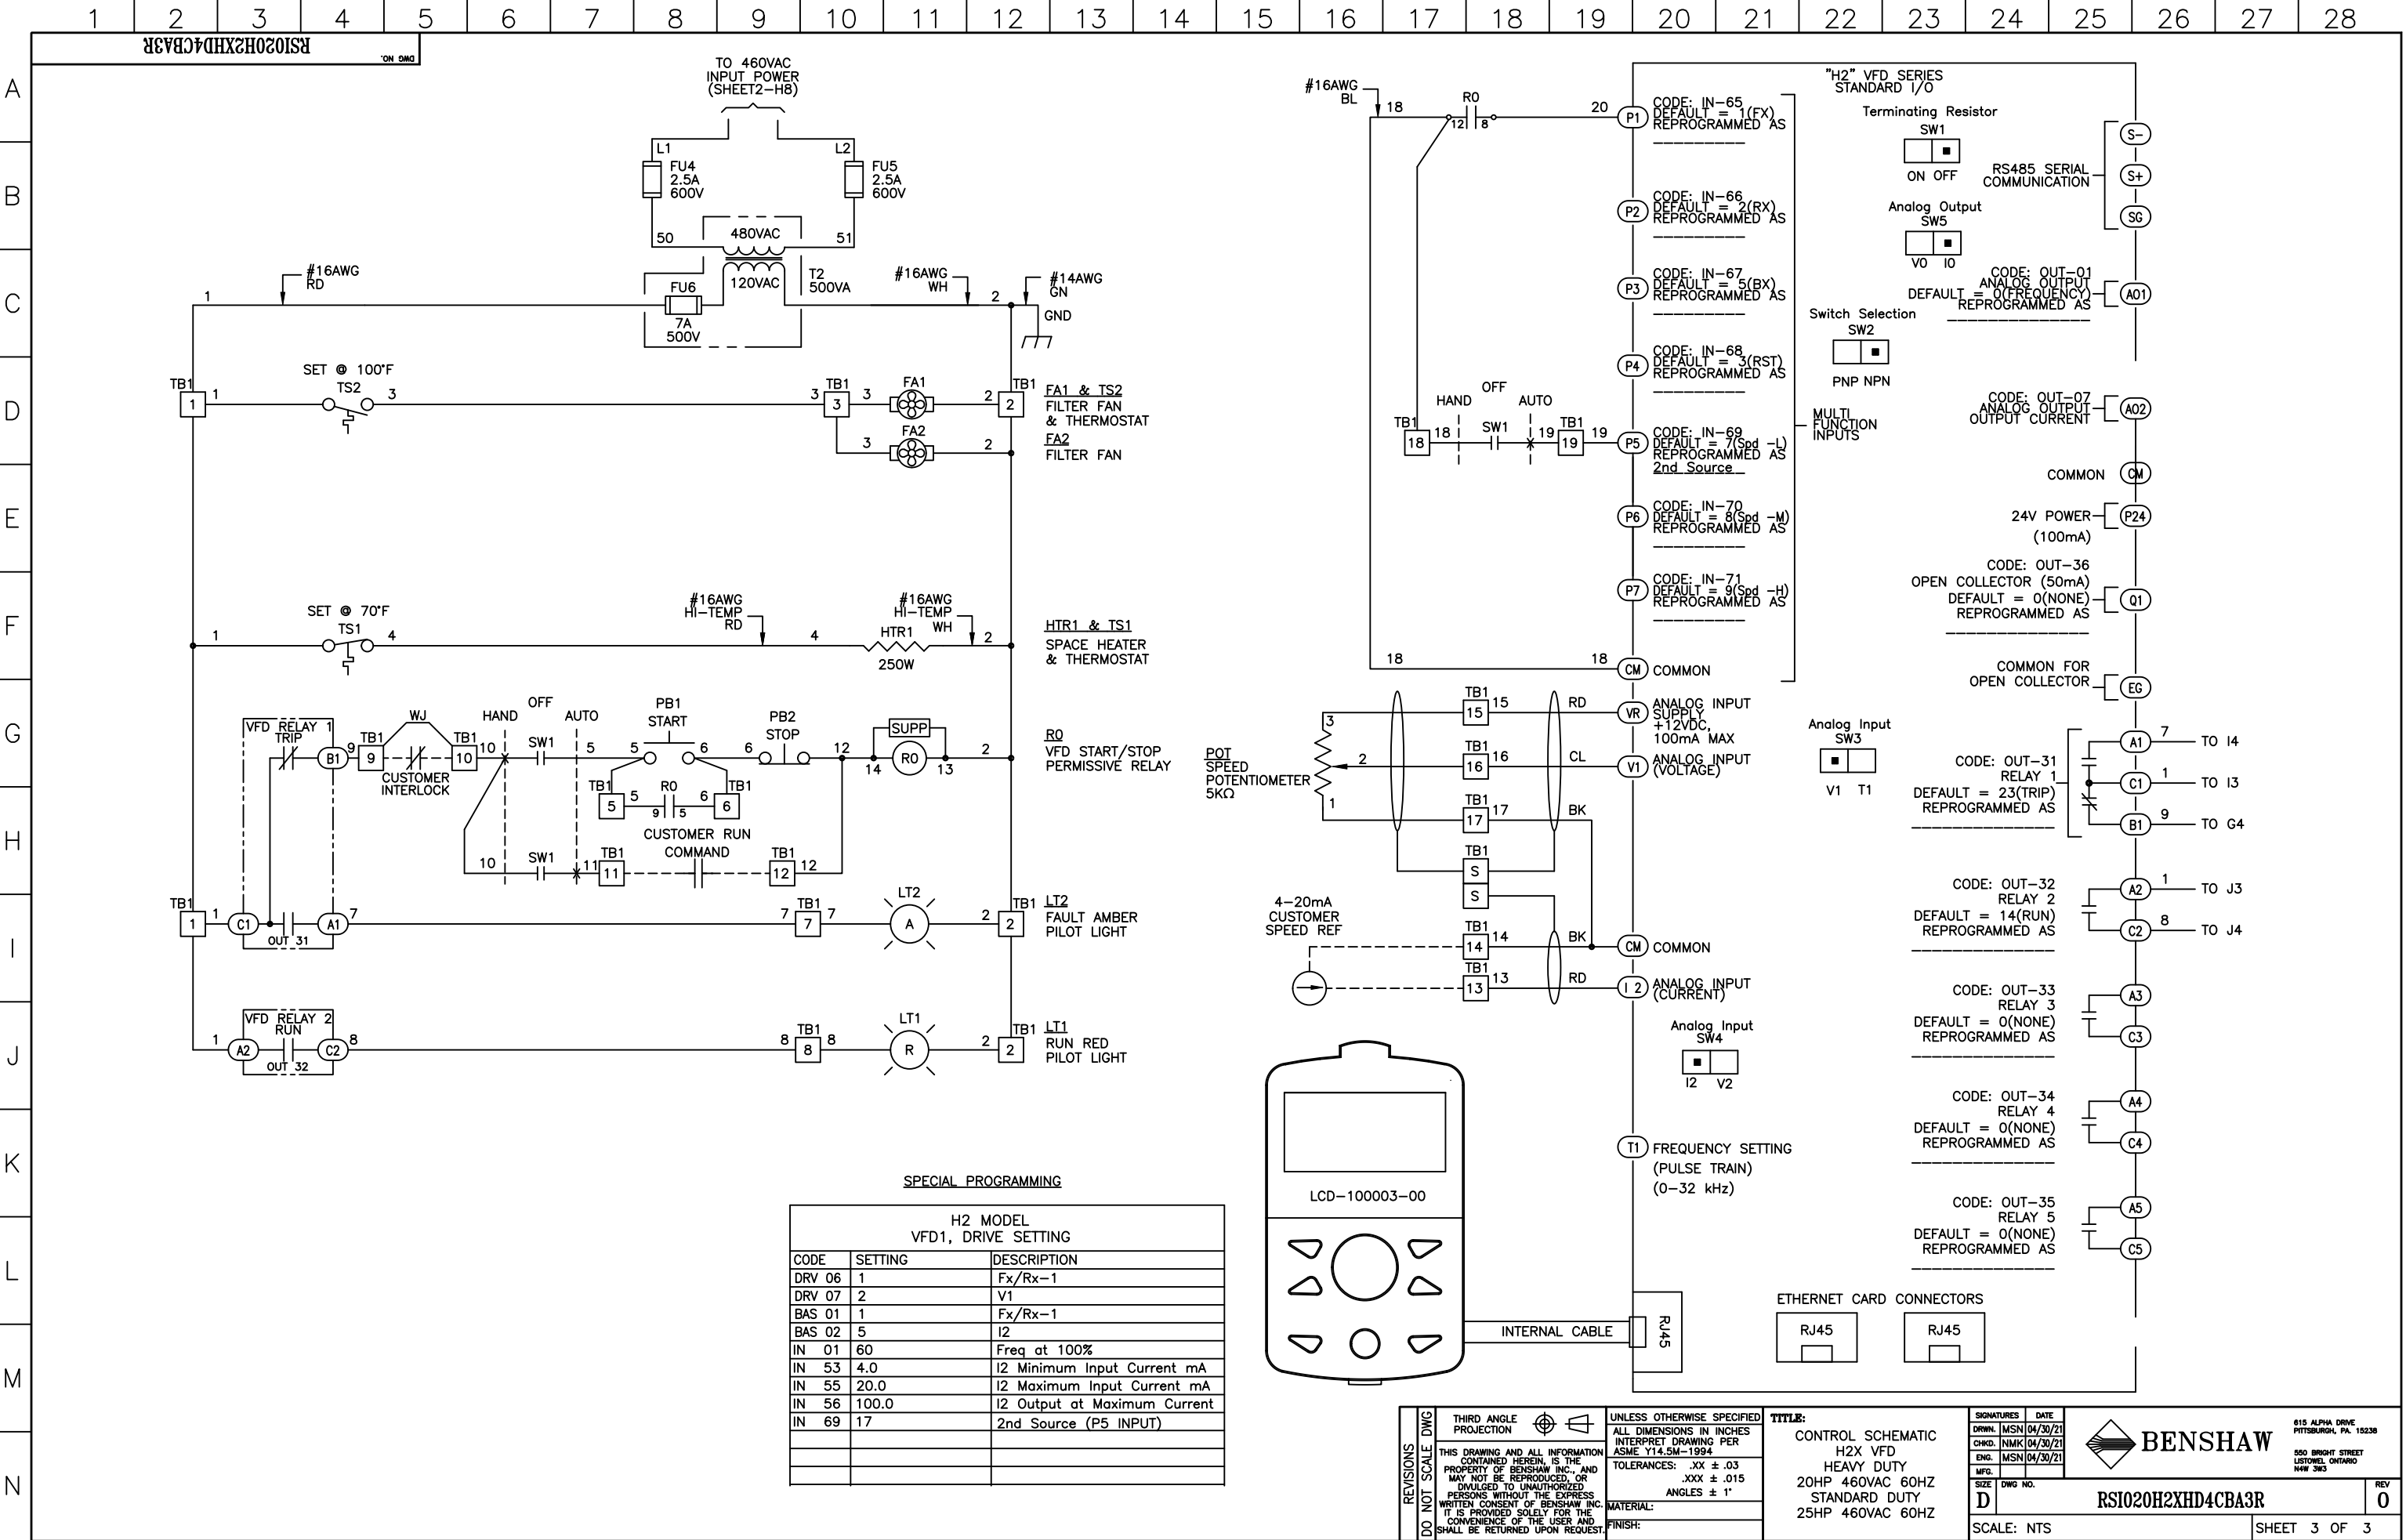

SPECIAL PROGRAMMING		
H2 MODEL VFD1, DRIVE SETTING		
CODE	SETTING	DESCRIPTION
DRV 06	1	Fx/Rx-1
DRV 07	2	V1
BAS 01	1	Fx/Rx-1
BAS 02	5	I2
IN 01	60	Freq at 100%
IN 53	4.0	I2 Minimum Input Current mA
IN 55	20.0	I2 Maximum Input Current mA
IN 56	100.0	I2 Output at Maximum Current
IN 69	17	2nd Source (P5 INPUT)

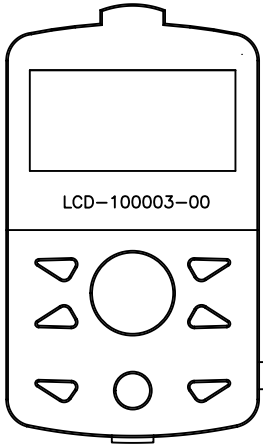

REVISIONS
DO NOT SCALE DWG

THIRD ANGLE PROJECTION

THIS DRAWING AND ALL INFORMATION CONTAINED HEREIN, IS THE PROPERTY OF BENSCHAW INC. AND MAY NOT BE REPRODUCED, OR DIVULGED TO UNAUTHORIZED PERSONS WITHOUT THE EXPRESS WRITTEN CONSENT OF BENSCHAW INC. IT IS PROVIDED SOLELY FOR THE CONVENIENCE OF THE USER AND SHALL BE RETURNED UPON REQUEST.

UNLESS OTHERWISE SPECIFIED

ALL DIMENSIONS IN INCHES INTERPRET DRAWING PER ASME Y14.5M-1994

TOLERANCES: .XX ± .03
.XXX ± .015
ANGLES ± 1°

MATERIAL:

FINISH:

TITLE:

CONTROL SCHEMATIC
H2X VFD
HEAVY DUTY
20HP 460VAC 60HZ
STANDARD DUTY
25HP 460VAC 60HZ

SIGNATURES

DATE

DRWN: MSN 04/30/21

CHKD: NIMK 04/30/21

ENG: MSN 04/30/21

MFG:

SIZE: D

DWG NO.

SCALE: NTS

BENSCHAW

815 ALPHA DRIVE
PITTSBURGH, PA. 15238

550 BRIGHT STREET
LITTON, ONTARIO
M4W 3W5

REV 0

SHEET 3 OF 3